


BASEMENT FLOOR PLAN

SCALE: 1/4" = 1'-0"

LEGEND

- POT LIGHT
- ◻ CEILING LIGHTING FIXTURE
- ⊗ SCENCE

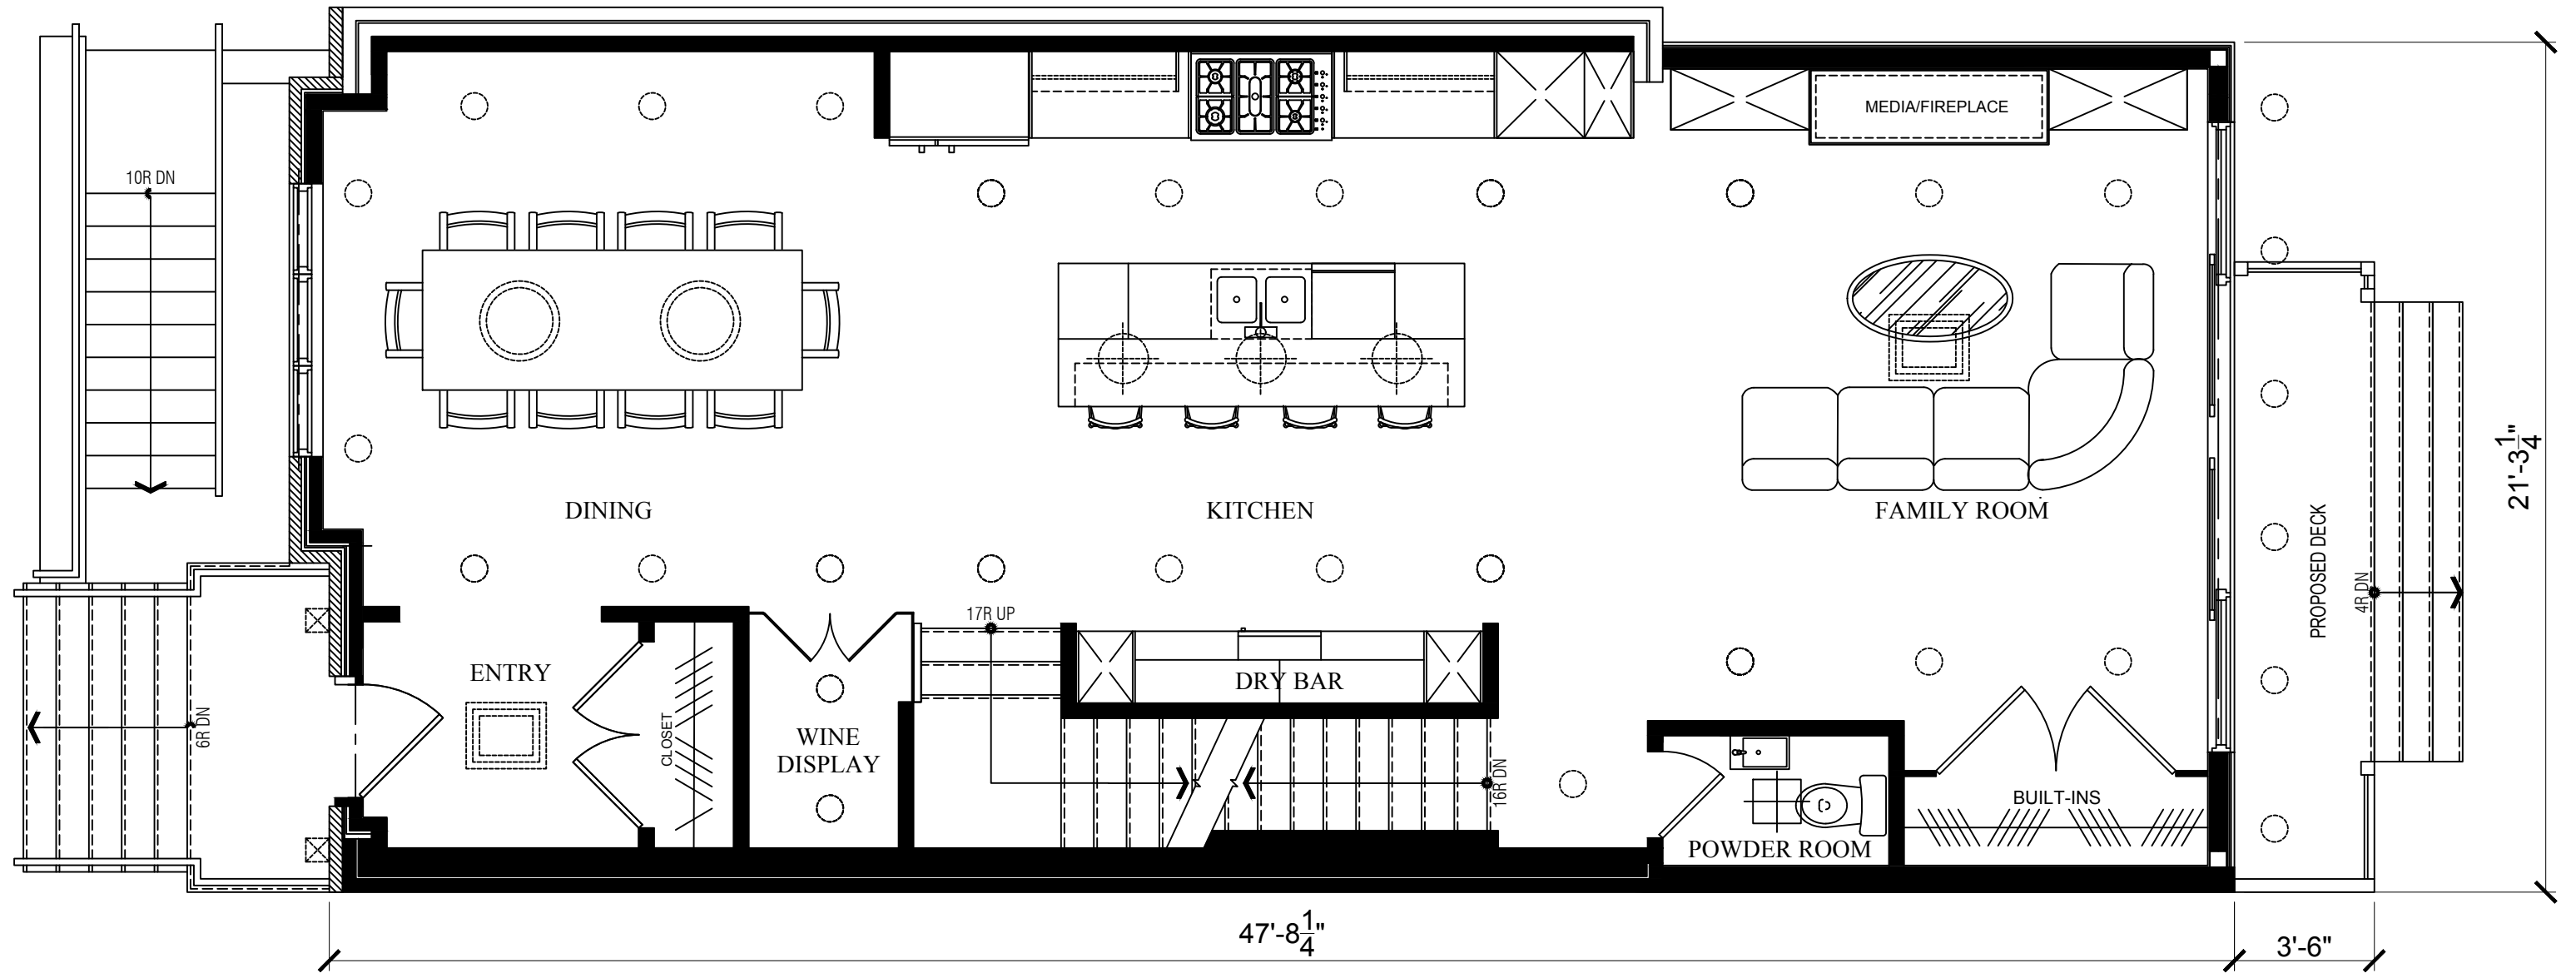


MAIN LEVEL FLOOR PLAN

SCALE: 1/4" = 1'-0"

LEGEND

- POT LIGHT
- LARGE PENDANT
- ◻ CEILING LIGHTING FIXTURE
- ⊕ PENDANT LIGHTING
- ⊗ SCONCE
- STRIP LIGHTING

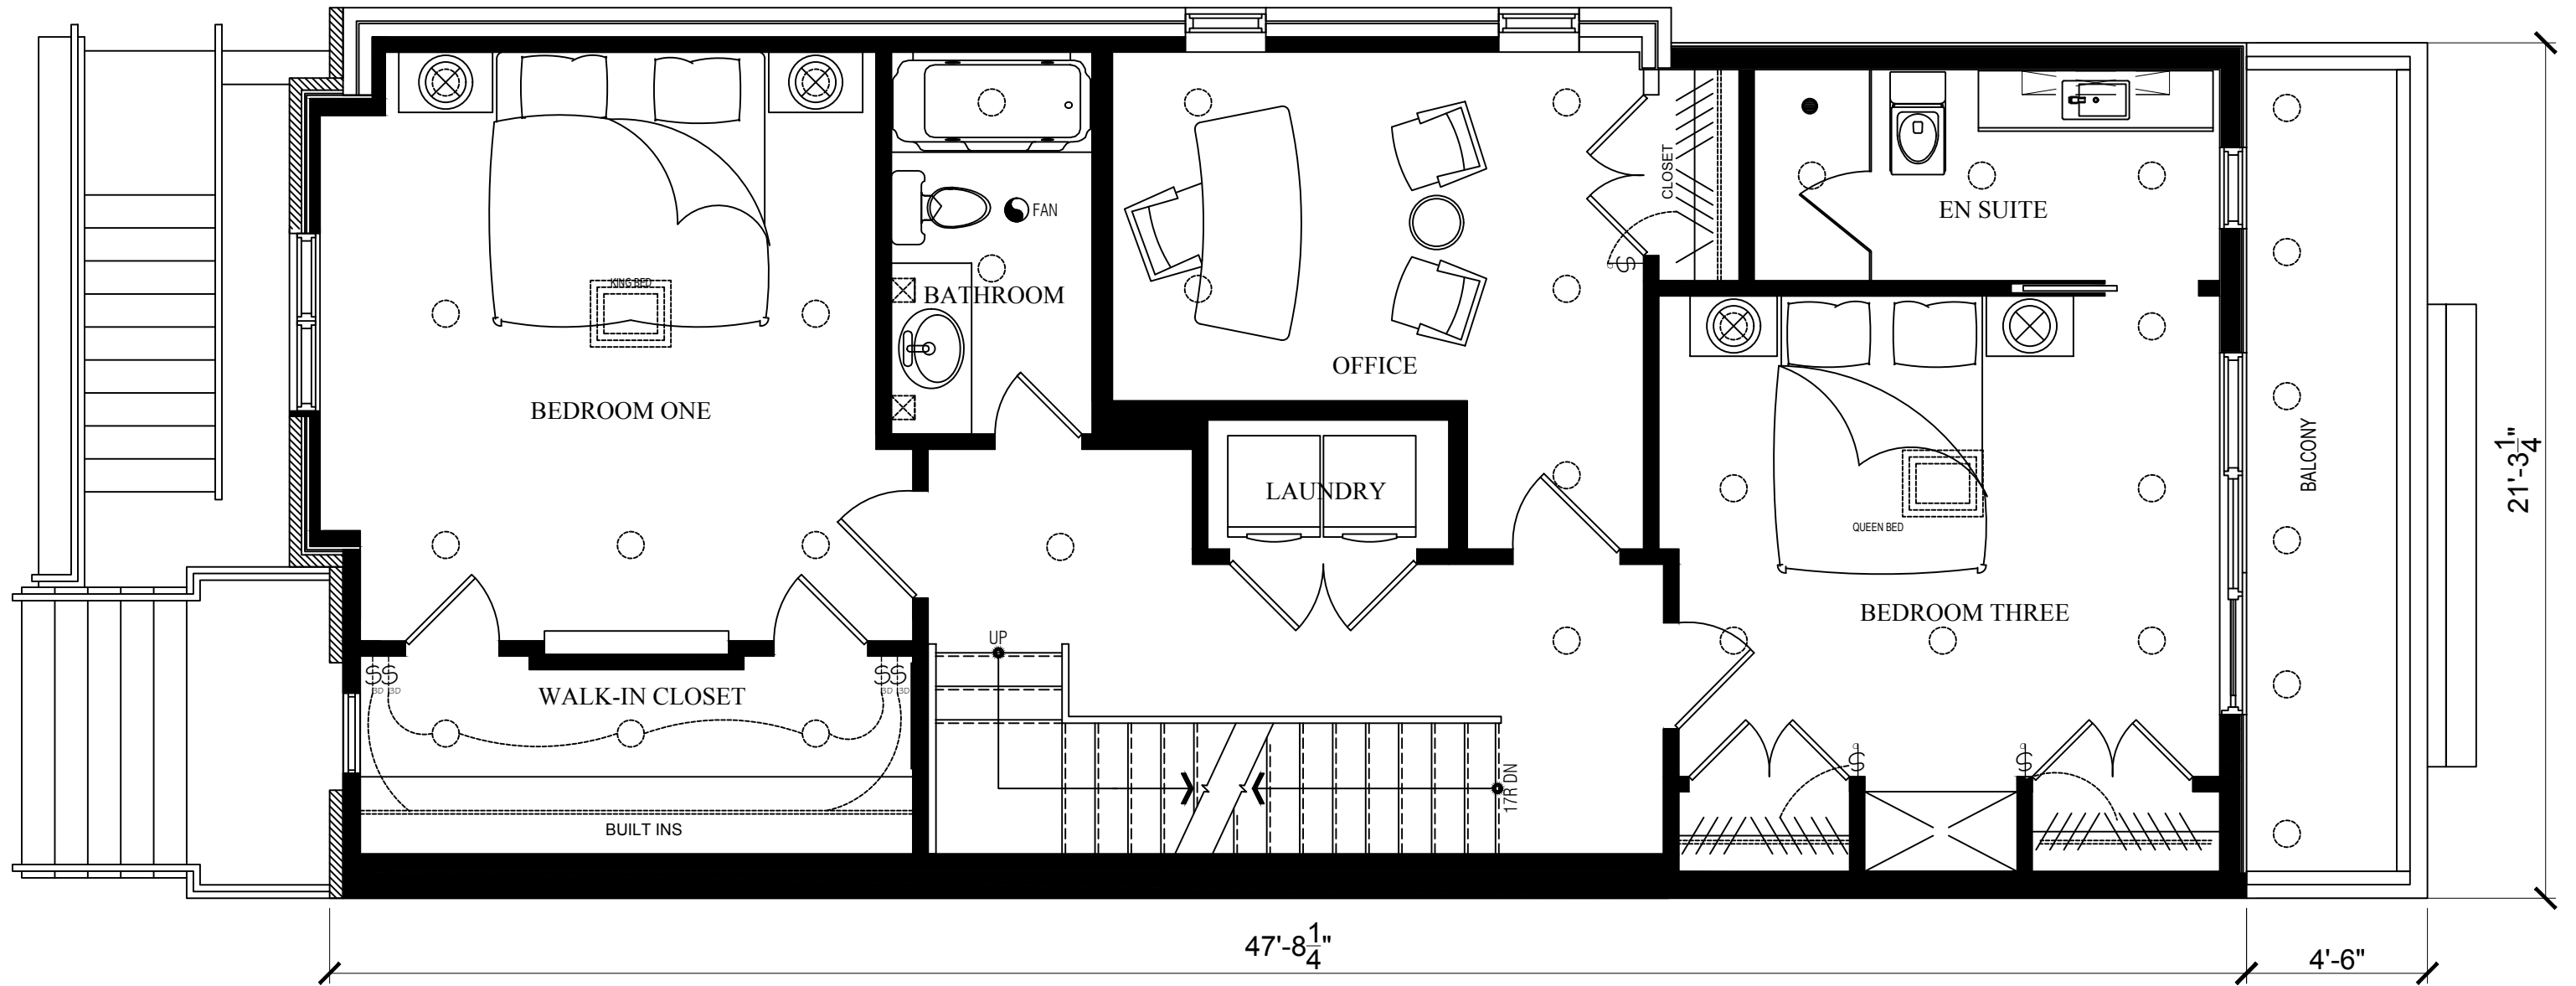


SECOND LEVEL FLOOR PLAN

SCALE: 1/4" = 1'-0"

LEGEND

- POT LIGHT
- ◻ CEILING LIGHTING FIXTURE
- ⊗ SCONCE
- ===== STRIP LIGHTING
- ⊗ ABOVE MIRROR FIXTURE

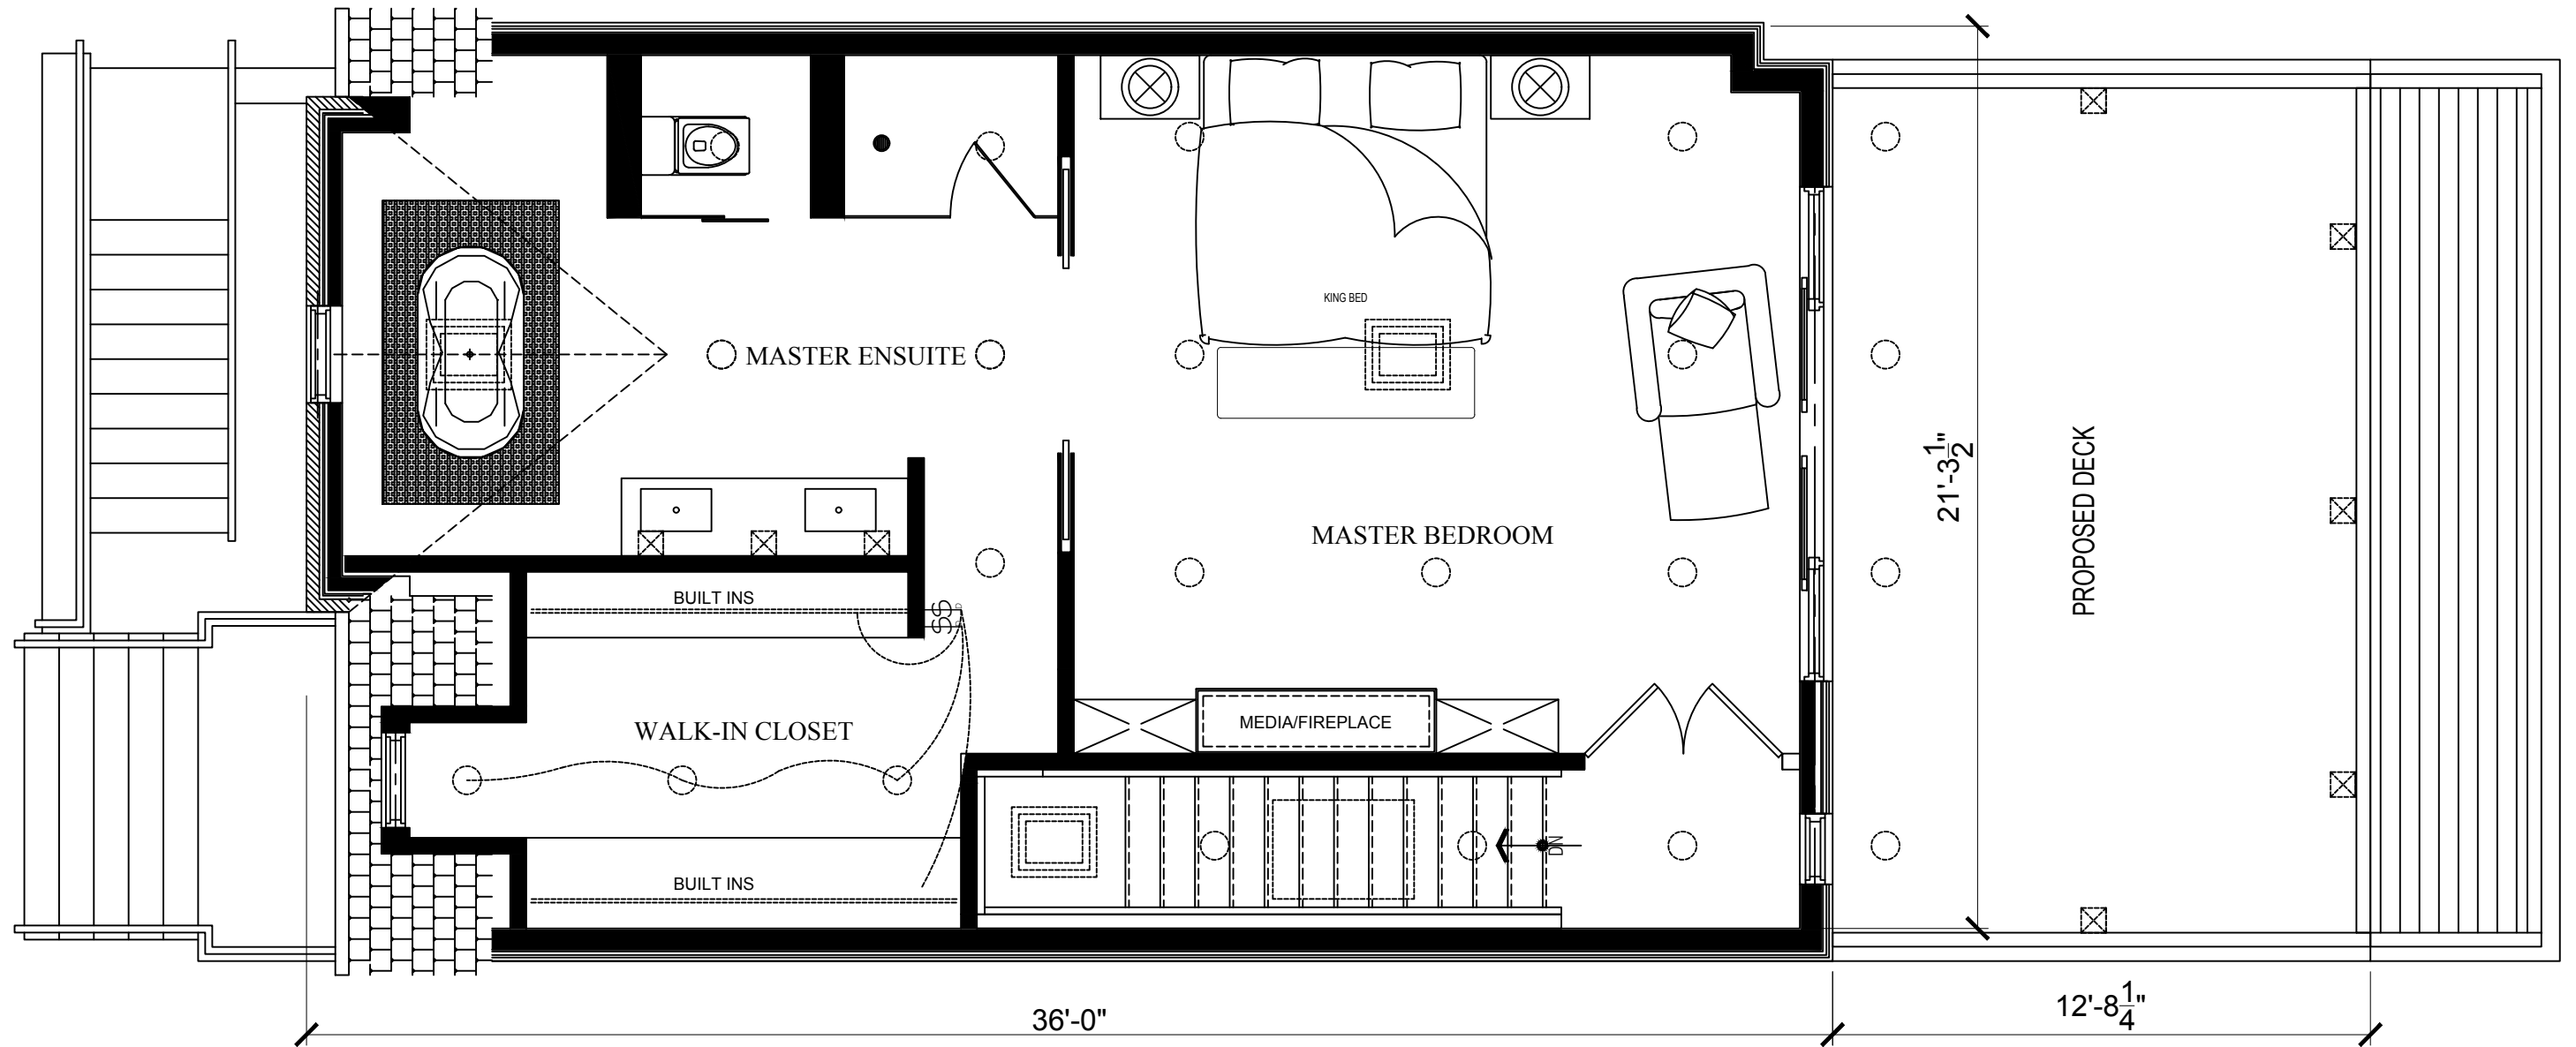

THIRD LEVEL FLOOR PLAN

SCALE: 1/4" = 1'-0"

LEGEND

- POT LIGHT ===== STRIP LIGHTING
- ◻ CEILING LIGHTING FIXTURE
- ⊠ SCONCE